

**ADDENDUM NO. 6**

January 21, 2022

This Addendum contains changes to the requirements of the Contract Documents and Specifications. Such changes are to be incorporated into the Construction Documents and shall apply to the work with the same meaning and force as if they had been included in the original document. Wherever this Addendum modifies a portion of a paragraph of the specifications or a portion of any Drawing, the remainder of the Paragraph or Drawing shall remain in force.

NOTE: Provisions of all Contract Documents apply.

---


Item 1. Attached is Drawing ED-112 PARTIAL THIRD, FOURTH, FIFTH AND SIXTH FLOOR DEMOLITION PLANS - ELEC., referenced in Addendum No. 5, Item 111, that is missing from the attachments

Attachments: Drawing ED-112

**\*\*\*\*END OF ADDENDUM\*\*\*\***


**DEMOLITION NOTES:**

1. DISCONNECT EXISTING PUMPS P-2 AND P-3 AND ASSOCIATED BRANCH CIRCUITING WIRING BACK TO SOURCE ALL CONTROLS, ETC., FOR REMOVAL BY MECHANICAL CONTRACTOR.
2. EXISTING PANEL CRY3 B34 FOR WILSON 3RD FLOOR CRYOGEN AREA. EXISTING 225A U.G. FEED TO SECTOR 7 AND EXISTING 250A U.G. FEED TO WILSON ROOM 128 VACUUM LAB RUN THROUGH TUNNEL. REPLACE SERVICES FOR BOTH AREAS DUE TO TUNNEL REMOVAL. REFER TO ONELINE DIAGRAM, SECTOR 7, AND WILSON OVERALL PLANS FOR ADDITIONAL REQUIREMENTS.
3. DISCONNECT AND REMOVE ANY EXISTING ELECTRICAL SYSTEMS IN PATIO STAIR BACK TO SOURCE.

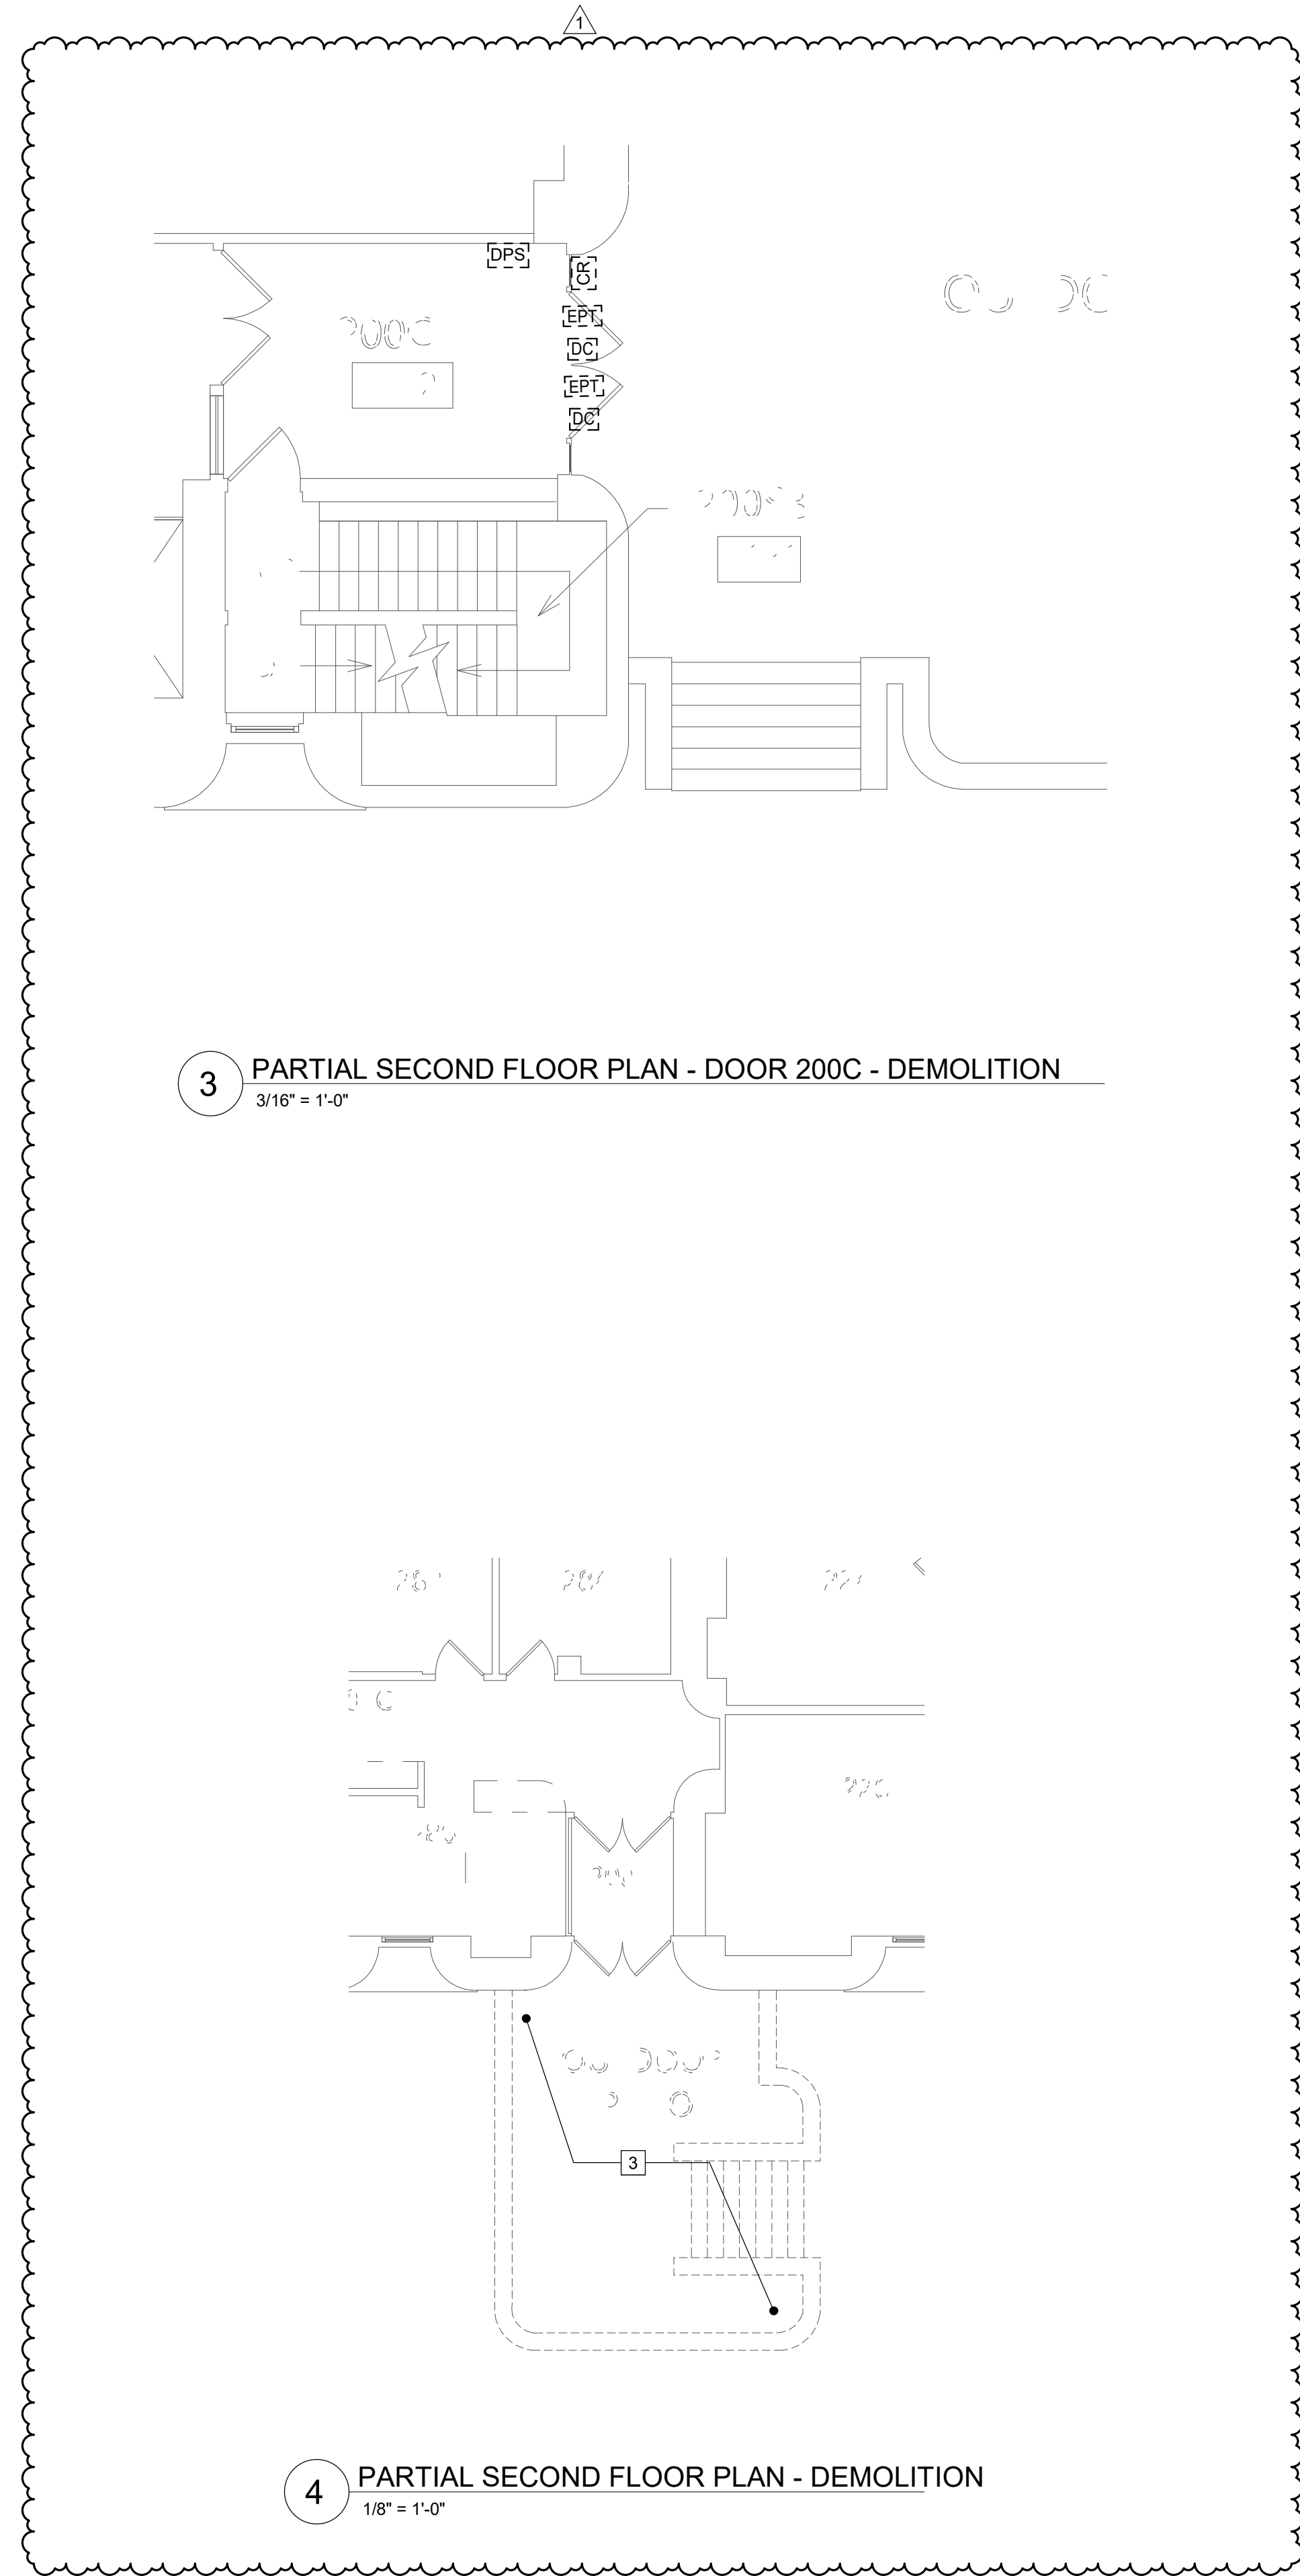

**3** PARTIAL SECOND FLOOR PLAN - DOOR 200C - DEMOLITION  
3/16" = 1'-0"

**4** PARTIAL SECOND FLOOR PLAN - DEMOLITION  
1/8" = 1'-0"

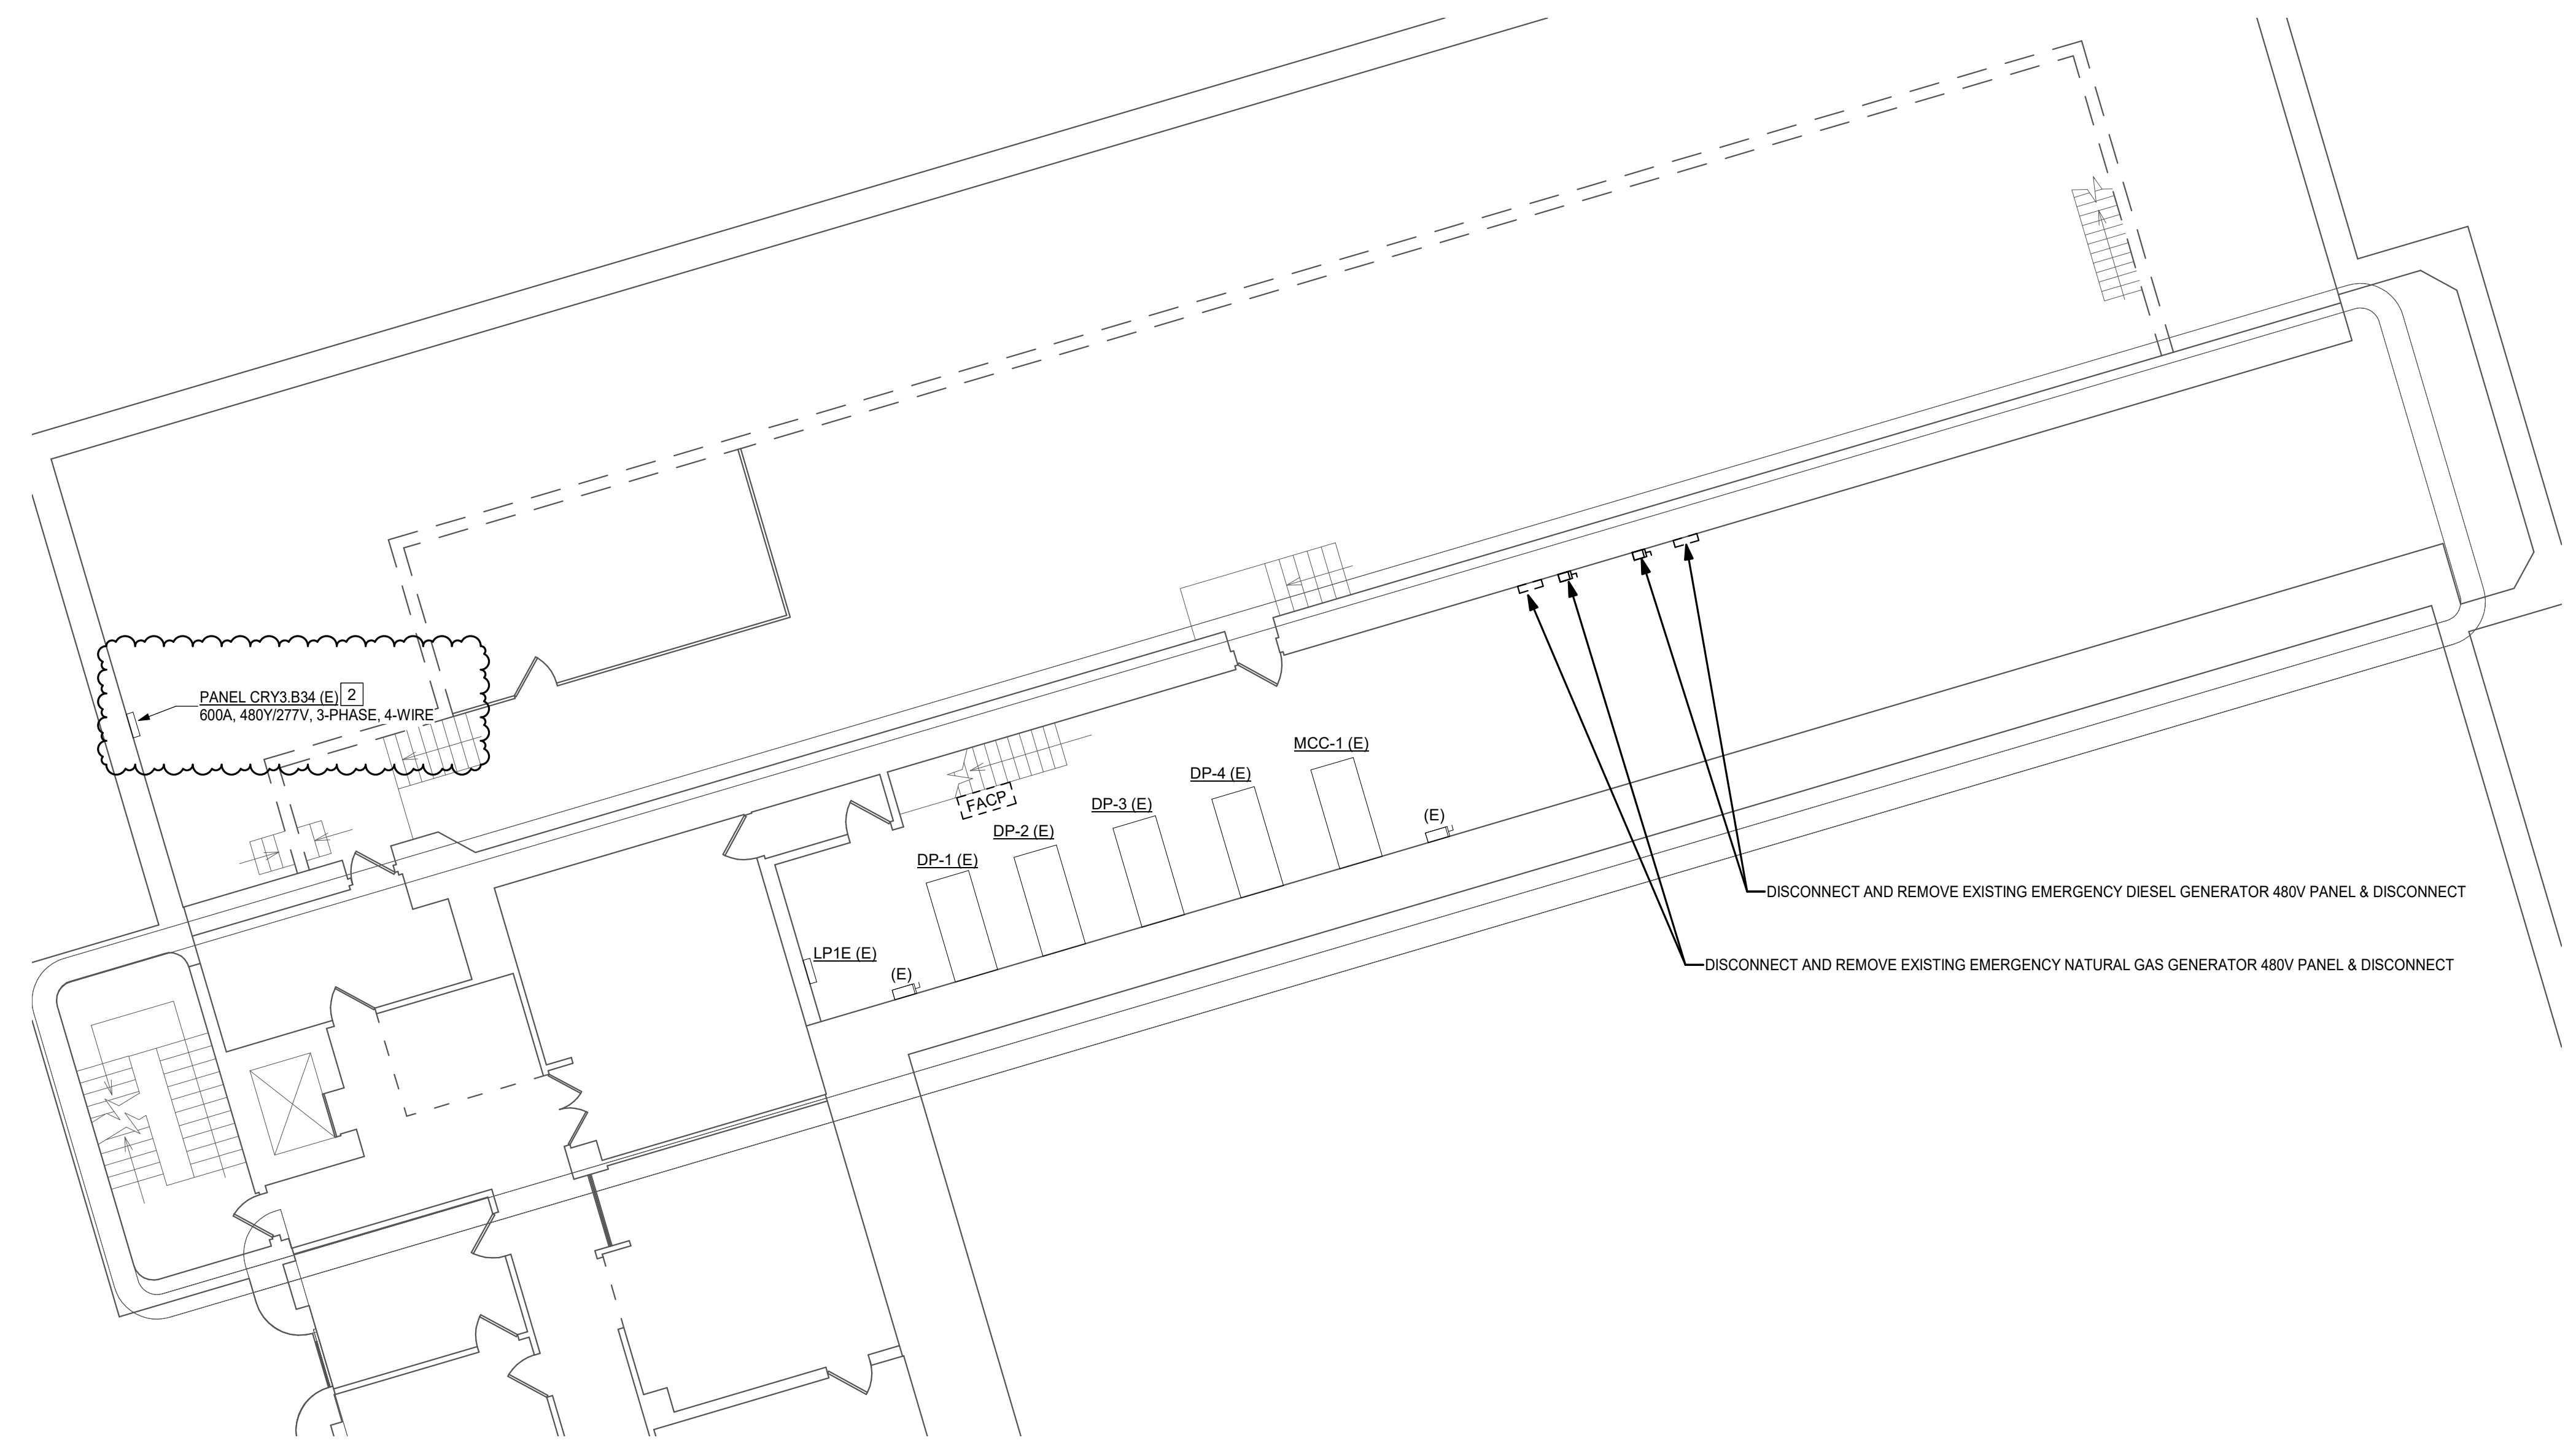

**1** Partial Third Floor Demolition Plan - ELEC  
1/8" = 1'-0"



**2** Partial Fourth Floor Demolition Plan - ELEC  
1/8" = 1'-0"



Drawn By: CRS  
Checked By: WRS  
Project Manager: GDD

These documents and all the ideas, arrangements, designs and plans indicated thereon or presented hereby are owned by and remain the property of SWBR and no part thereof shall be utilized by any person, firm, or corporation for any purpose whatsoever except with the specific written permission of SWBR. All rights reserved. ©

**Revisions**

1	01/18/22	Addendum no. 5
---	----------	----------------

CHESSE New Experimental Hall  
Synchrotron Drive  
Ithaca, NY 14853  
SWBR Project Number 20657.00

Cornell University  
Ithaca, NY 14853

**ED-112**  
Partial Third, Fourth, Fifth and Sixth Floor Demolition Plans - ELEC

December 6, 2021  
100% Construction Documents