

ADDENDUM NO. 1

May 25, 2022

This Addendum contains changes to the requirements of the Contract Documents and Specifications. Such changes are to be incorporated into the Construction Documents and shall apply to the work with the same meaning and force as if they had been included in the original document. Wherever this Addendum modifies a portion of a paragraph of the specifications or a portion of any Drawing, the remainder of the Paragraph or Drawing shall remain in force.

NOTE: Provisions of all Contract Documents apply.

Item 1. INSTRUCTIONS TO BIDDERS, INS-1, 3. METHOD OF SUBMISSION

DELETE in its entirety.

- b. Proposals shall be delivered to the Owner at the address listed above not later than 2:00PM on May 26, 2022.

REPLACE with:

- b. Proposals shall be delivered to the Owner at the address listed above not later than **3:00PM on June 2, 2022.**

Item 2. Drawing A101, Details C4 and E4 FOURTH FLOOR PLAN

DELETE Note "SURFACE MOUNTED SCONCE" in its entirety.

REPLACE with:

"F.C, SURFACE MOUNTED SCONCE"

Item 3. Drawing A151

DELETE in its entirety.

REPLACE with revised Drawing A151R1, attached.

Item 4. Drawing A451

DELETE in its entirety.

REPLACE with revised Drawing A451R1, attached.

Modify Atrium Lighting & Sprinklers – Mann Library
Addendum No. 1
May 25, 2022
Page 2

Item 5. RFI Questions and Clarifications

See attached RFI Log (1 - 2)

Attachments Drawing A151R1
 Drawing A451R1
 RFI Log (1 – 2)

******END OF ADDENDUM******

1 2 3 4 5 6 7 8 9 10

G

F

E

 
 

D


C

B

A

OTHER:
 • SPRINKLER HEAD

 LIGHT FIXTURES:
 LINEAR SURFACE MOUNTED UPLIGHT FIXTURE
 RECESSED LINEAR LIGHT FIXTURE (OPTION 1)
 RECESSED CAN LIGHT FIXTURE (OPTION 2)

CEILING MATERIALS:
 GYPSUM BOARD CEILING

REFLECTED CEILING PLAN NOTES:
 1. ALL GYPSUM SOFFITS ARE TO BE PATCHED AND PAINTED TO MATCH EXISTING FINISH.


LIGHTING FIXTURE SCHEDULE										
LABEL	DESCRIPTION	MANUFACTURER	MODEL	VOLTAGE	LAMP TYPE	TOTAL WATTS	FINISH	MOUNTING	DRIVER LOCATION	NOTES
FA	SURFACE MOUNTED IN ARCHITECTURAL COVE CONTINUOUS LINEAR LED UPLIGHT WITH 120° DISTRIBUTION AND INTEGRAL DIMMING DRIVER.	ECOSENSE	L35-I(LENGTH)-12-35-80-MULT-120	PER EE	3500K WHITE LED	12WLF	-	SURFACE MOUNTED	INTEGRAL	MOCKUP REQUIRED. LINEAR FIXTURE IS TO DELIVER A 120° BEAM ANGLE AND TO BE CONCEALED WITHIN COVE LIGHTING SHELF. OUTPUT IS TO PROVIDE A FLICKER FREE DIMMING DOWN TO 0%. LISTED MANUFACTURER OR EQUAL ARE ACCEPTABLE REPLACEMENTS.
FB	RECESSED FLANGELESS LED DOWNLIGHT WITH NOMINAL 4" DIAMETER APERTURE, DIFFUSE SATIN OPAL LENS, AND INTEGRAL DIMMING DRIVER.	INTER-LUX WHITEGOODS	WG-100RPTD-RPT-H-935-(DRIVER)-FRDCLAM-(FINISH)-(OPTIONS)	PER EE	3500K WHITE LED	23W	WHITE	RECESSED	INTEGRAL	ROUND RECESSED 4" DIAMETER WITH FLUSH PLASTER TRIM AND INTEGRAL DRIVER. FIXTURE AND DRIVER DEPTH TO BE NO MORE THAN 3.3". LISTED MANUFACTURER OR EQUAL ARE ACCEPTABLE REPLACEMENTS.
FC	12" DIAMETER DECORATIVE WALL MOUNTED SCONCE	KONCEPT	RMW-12-SW-PTB-HW	120	3000K WHITE LED	18W	PAINTABLE	SURFACE MOUNTED	INTEGRAL	ROUND 12" DIAMETER WITH INTERCHANGEABLE MAGNETICALLY ATTACHED FACE PLATES. ROUND BOWL SHAPE BODY IS TO EMIT 360° OF DIFFUSED LIGHT. LISTED MANUFACTURER OR EQUAL ARE ACCEPTABLE REPLACEMENTS.

Chiang | O'Brien
ARCHITECTS




WARNING: It is a violation of New York State Law for any person, unless acting under the direction of a licensed Architect, to alter this document in any way. If a document bearing the seal of an Architect is altered, the altering Architect shall affix to such document his seal and the notation "altered by" followed by his signature, the date of such alteration, and a specific description of the alteration.


REVISION SCHEDULE		
#	DESCRIPTION	DATE
1	ADD. 1	05/25/22

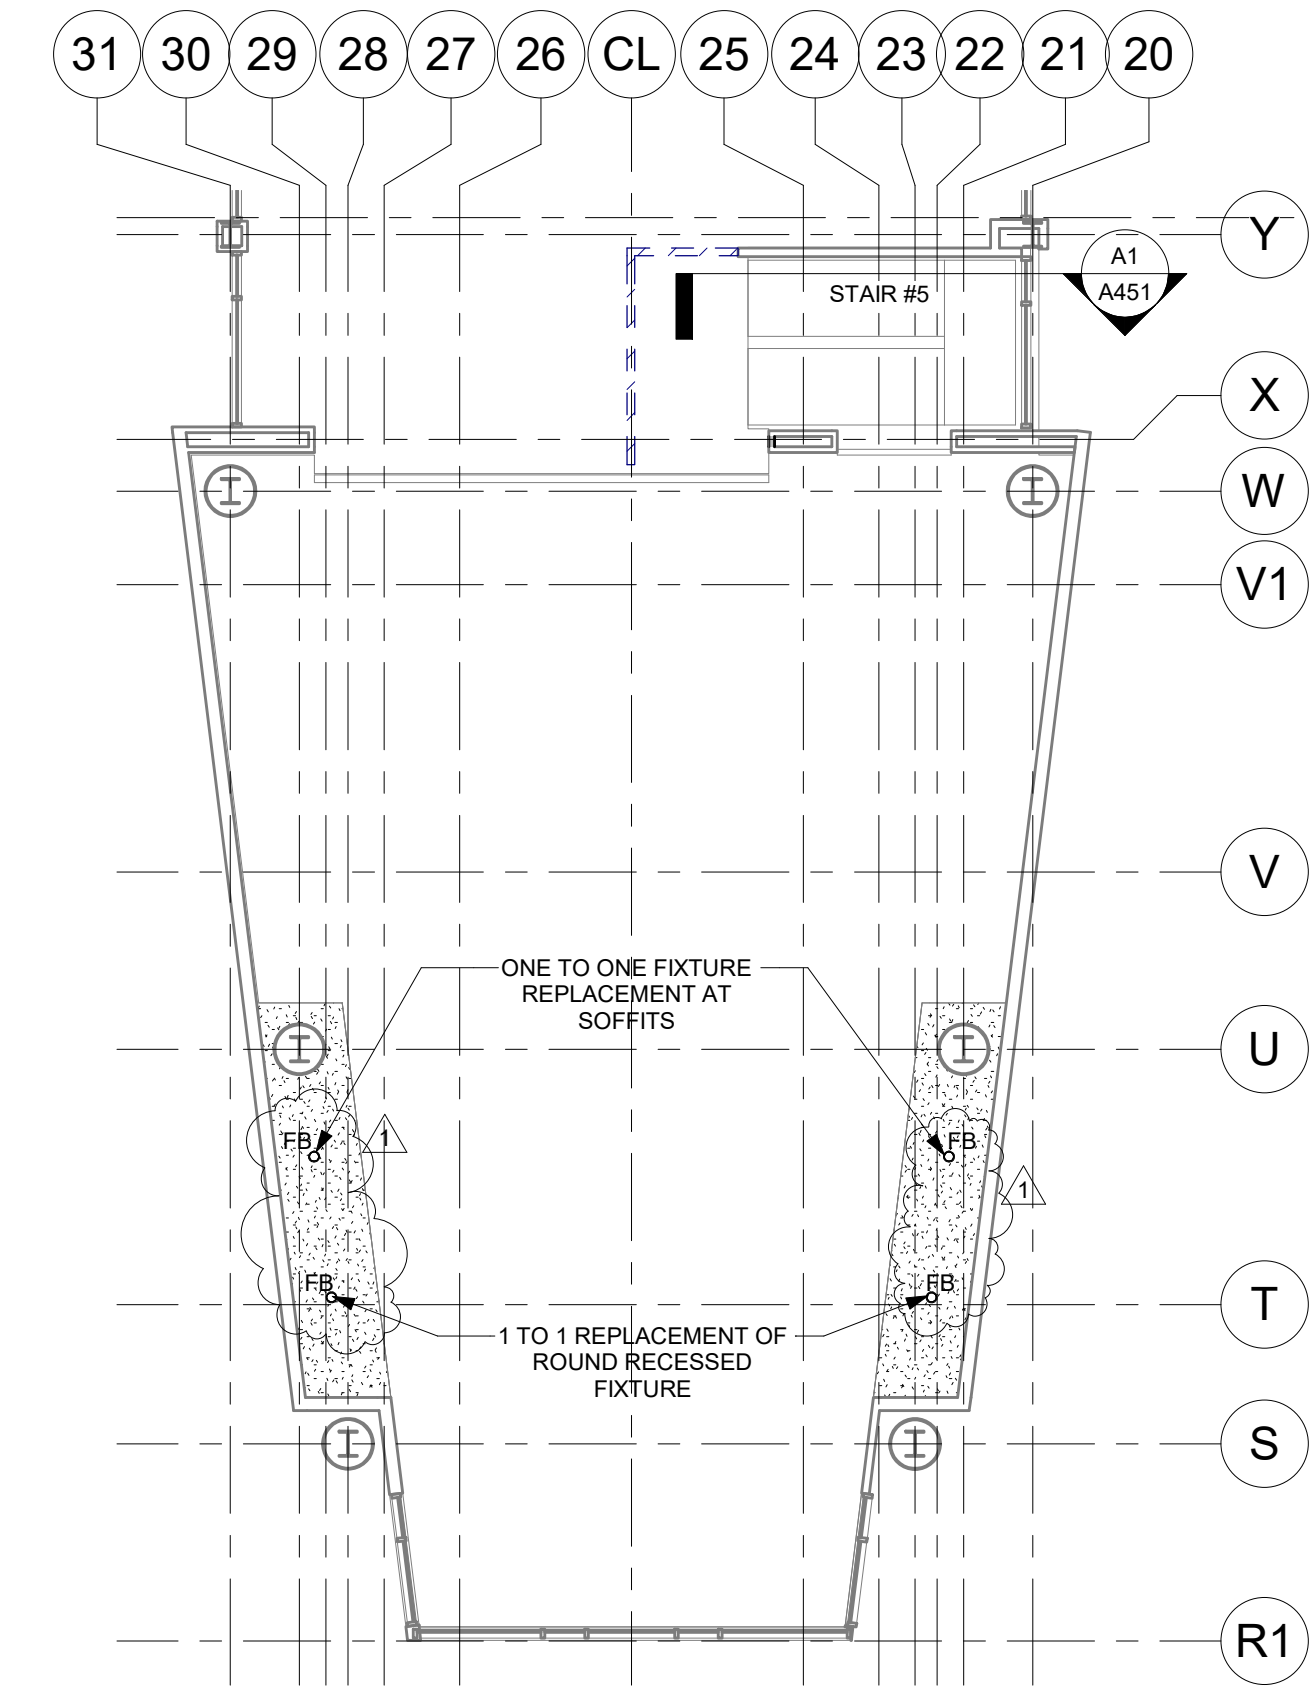

A1 SECOND FLOOR REFLECTED CEILING PLAN
1/8" = 1'-0"

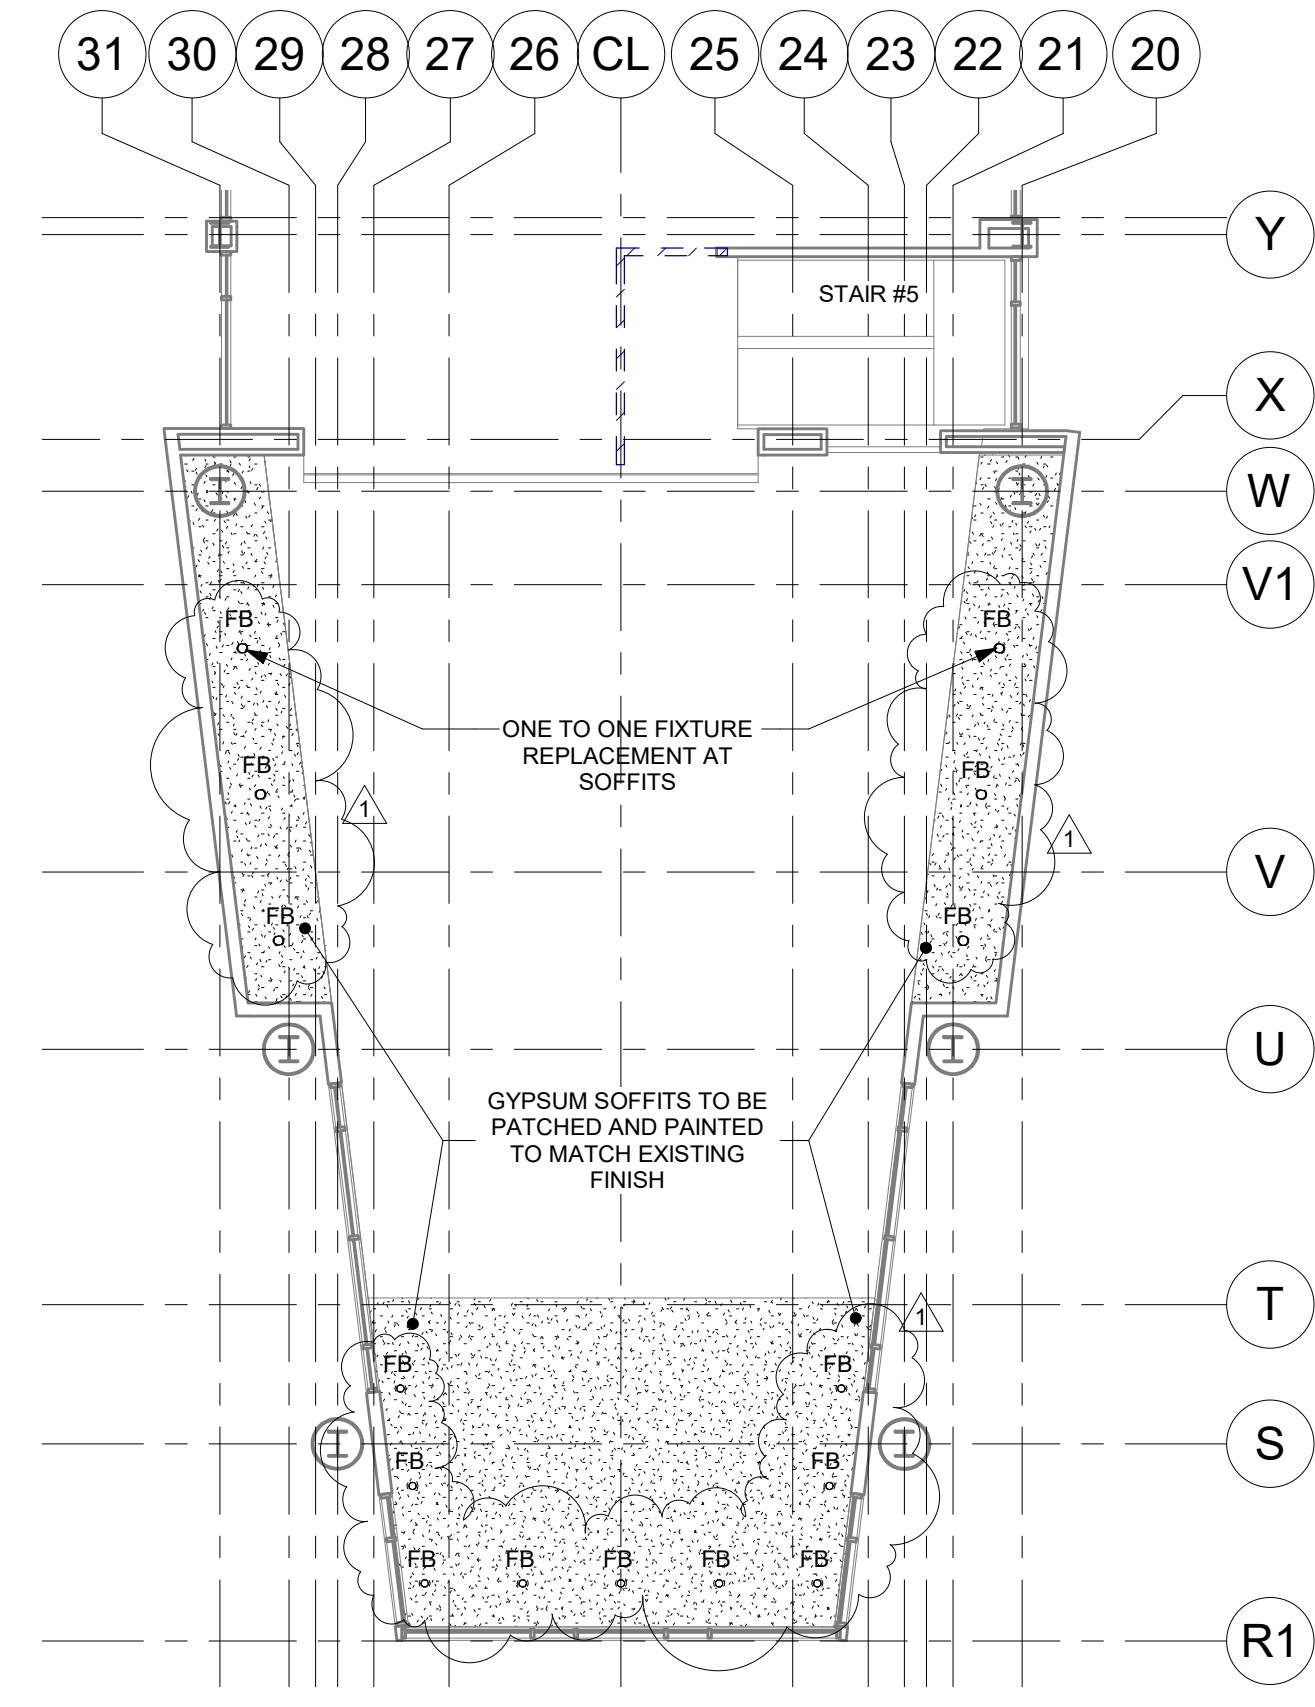

A4 THIRD FLOOR REFLECTED CEILING PLAN
1/8" = 1'-0"

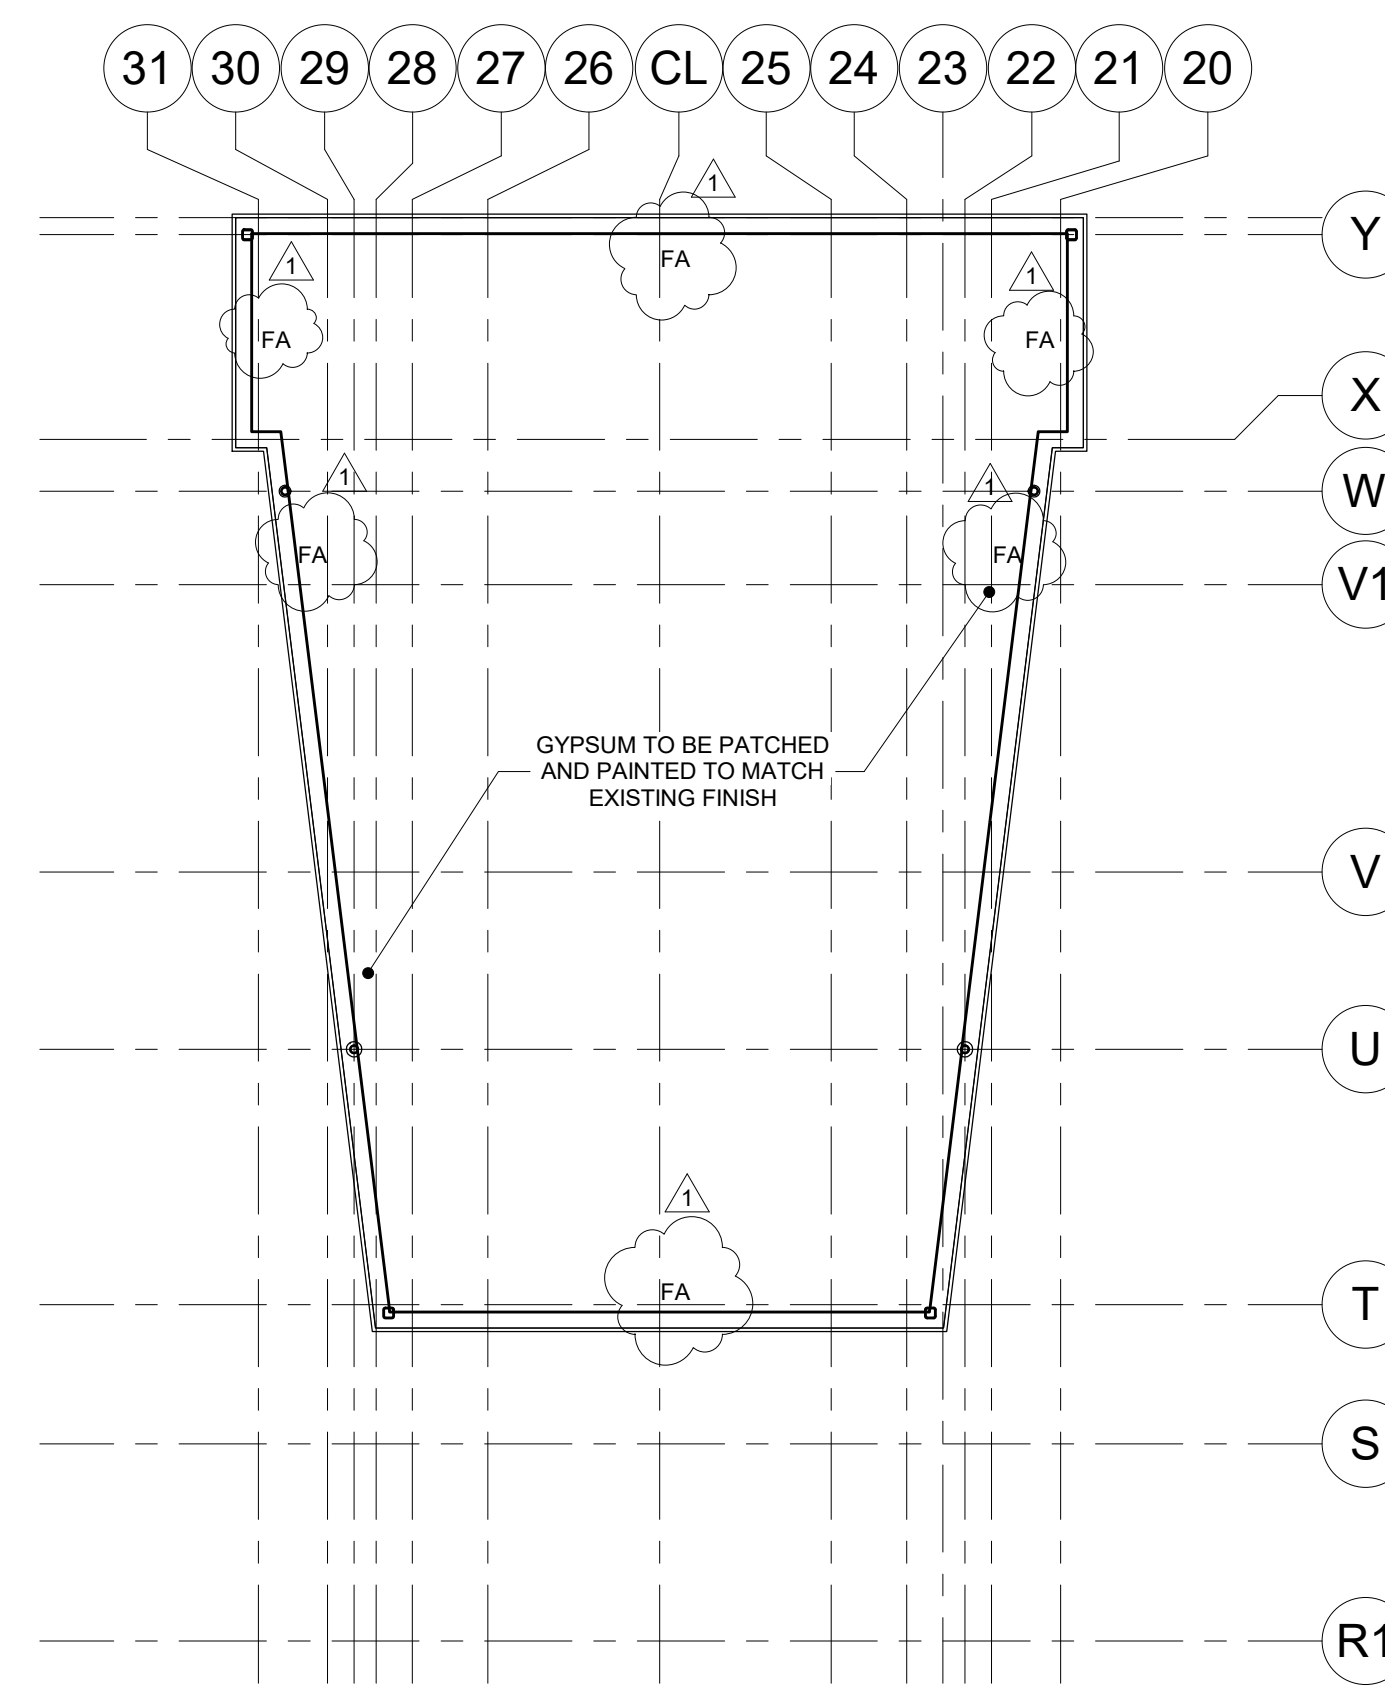

A7 ROOF REFLECTED CEILING PLAN
1/8" = 1'-0"

100% CONSTRUCTION DOCUMENTS
**SUCF 161039 - Modify Atrium
 Lighting & Sprinklers-Mann Library**
 237 Mann Drive, Ithaca, NY 14853

DATE: March 25, 2022
 PROJECT: COB# 2017
 OTHER:
 DRAWN BY: Author

PARTIAL
 REFLECTED
 CEILING PLANS

A151R1



WARNING: It is a violation of New York State Law for any person, unless acting under the direction of a licensed Architect, to alter this document in any way. If a document bearing the seal of an Architect is altered, the altering Architect shall affix to such document his seal and the notation "altered by" followed by his signature, the date of such alteration, and a specific description of the alteration.


REVISION SCHEDULE		
#	DESCRIPTION	DATE
1	ADD. 1	05/25/22

100% CONSTRUCTION DOCUMENTS
**SUCF 161039 - Modify Atrium
 Lighting & Sprinklers-Mann Library**
 237 Mann Drive, Ithaca, NY 14853

DATE:	March 25, 2022
PROJECT:	COB# 2017
OTHER:	
DRAWN BY:	Author


ELEVATIONS,
SECTIONS AND
DETAILS

A451R1

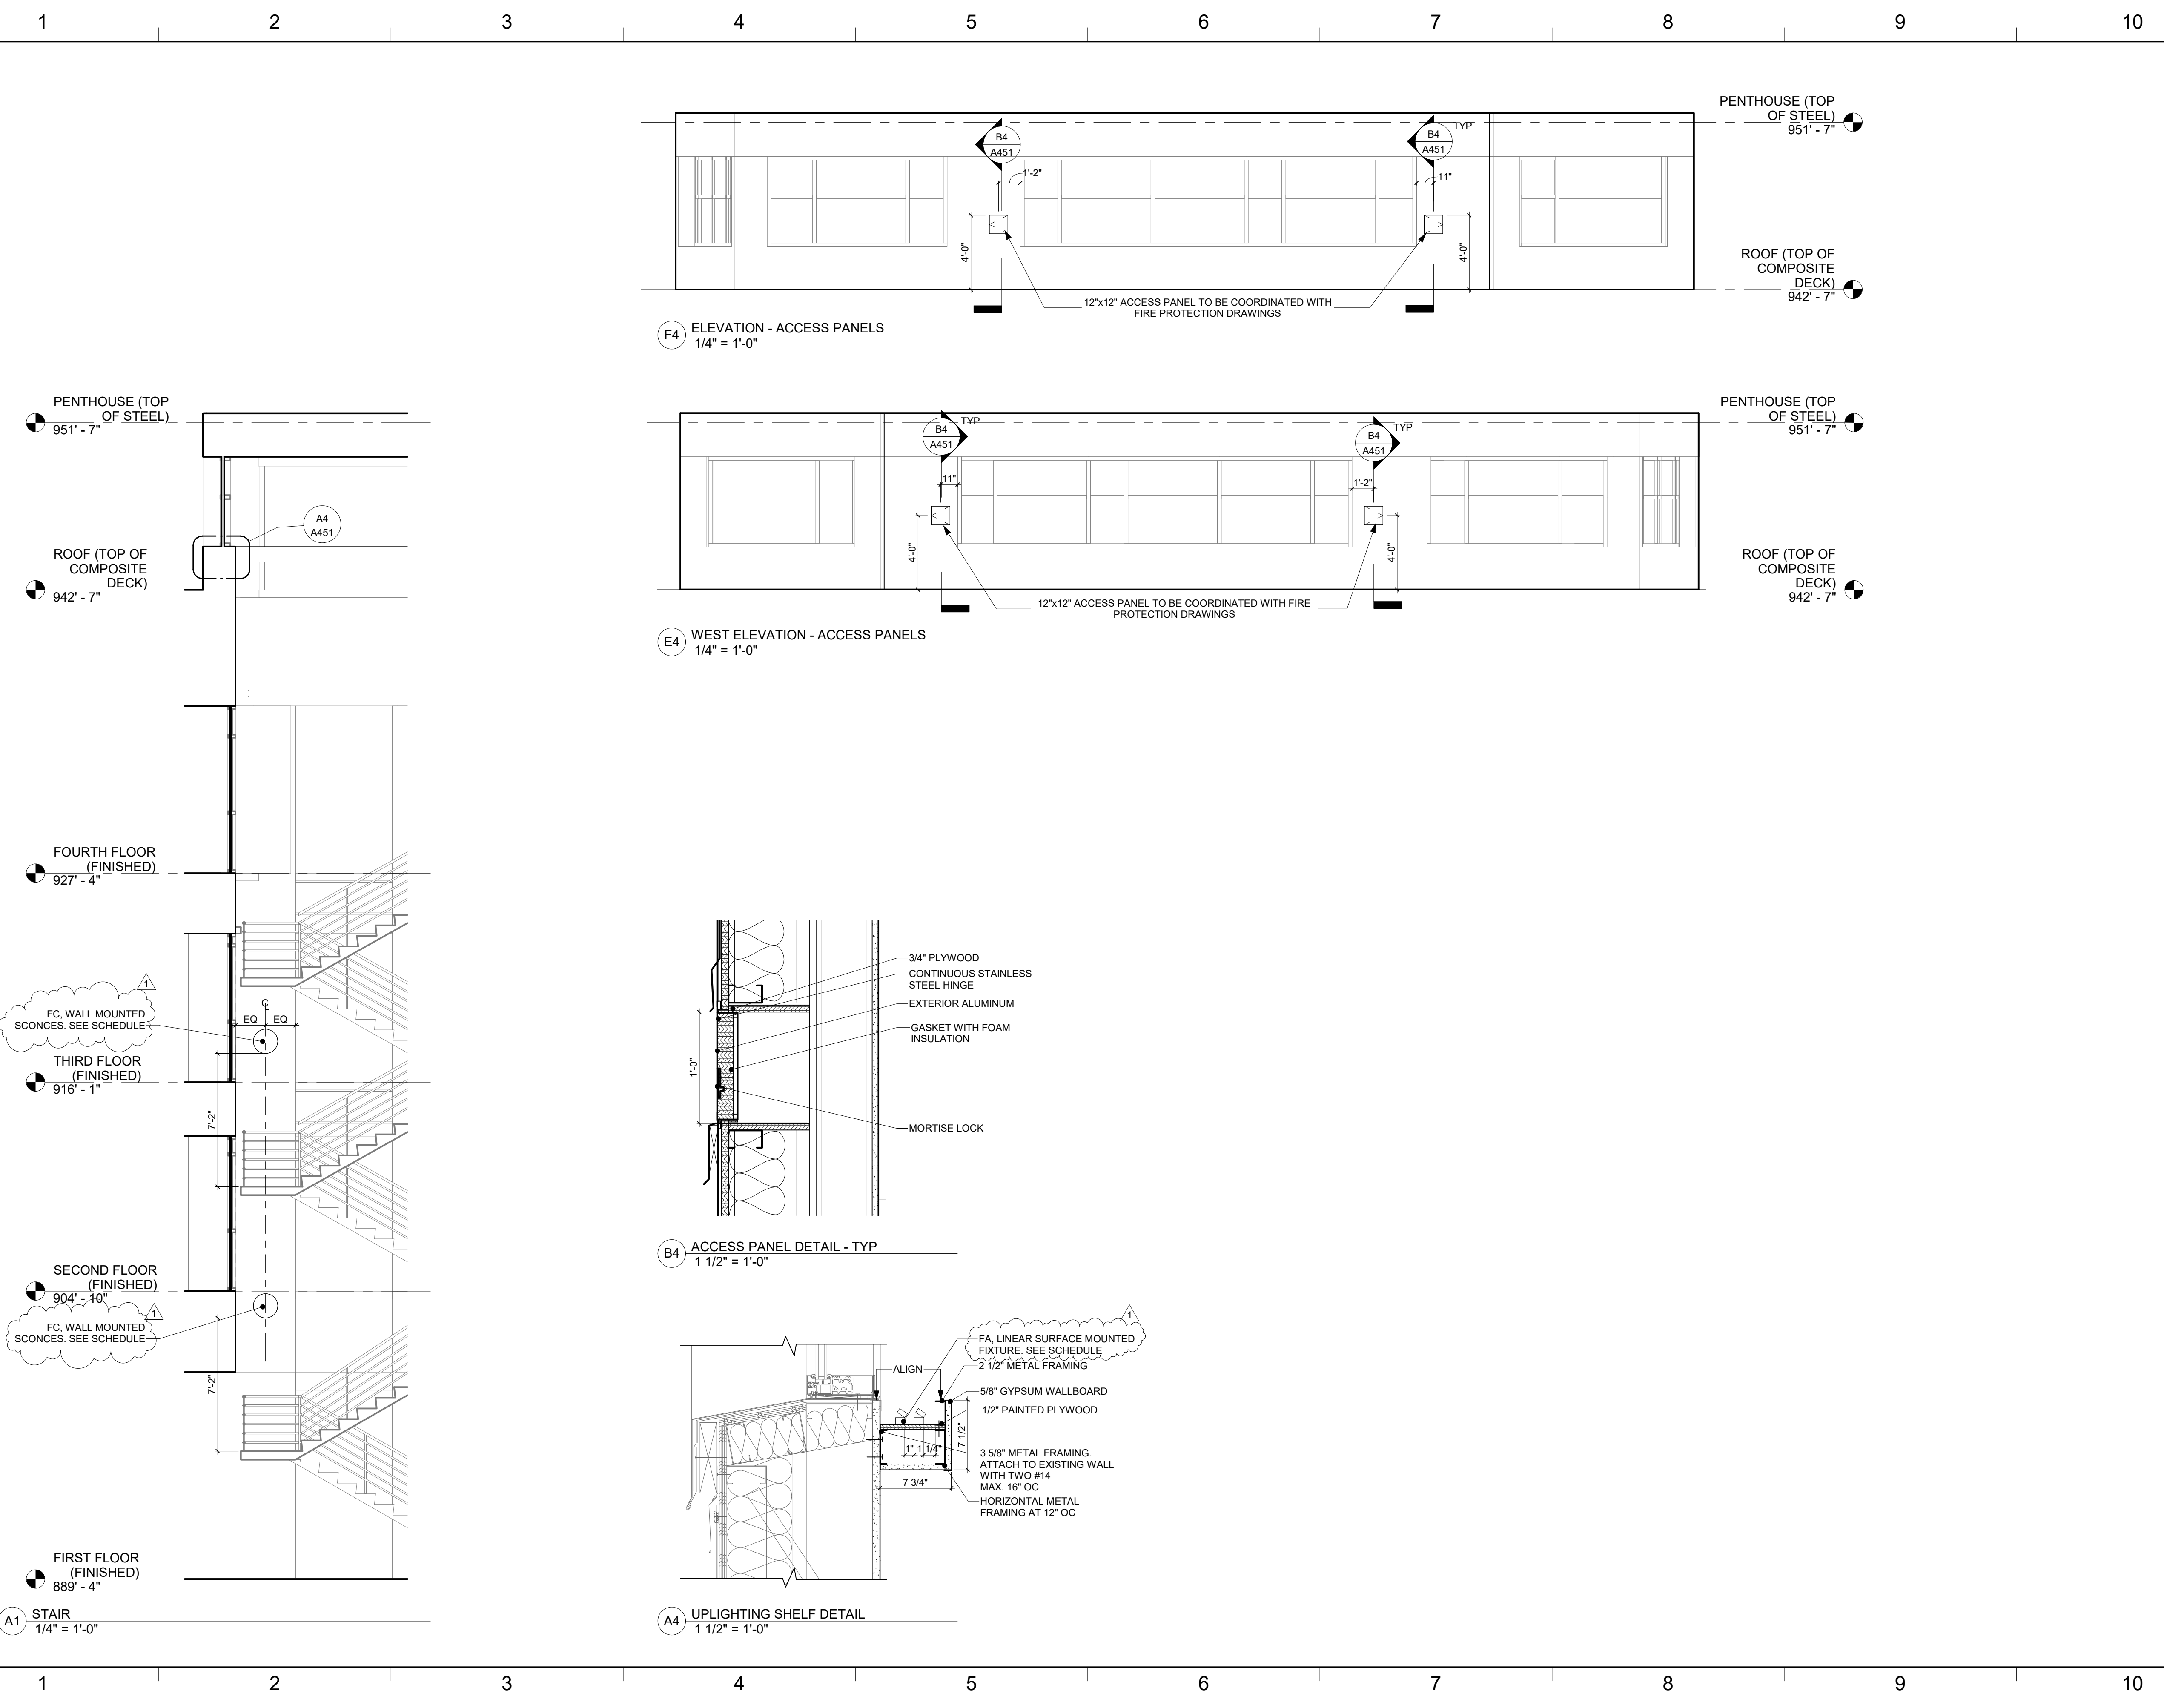

F4 ELEVATION - ACCESS PANELS
1/4" = 1'-0"

E4 WEST ELEVATION - ACCESS PANELS
1/4" = 1'-0"

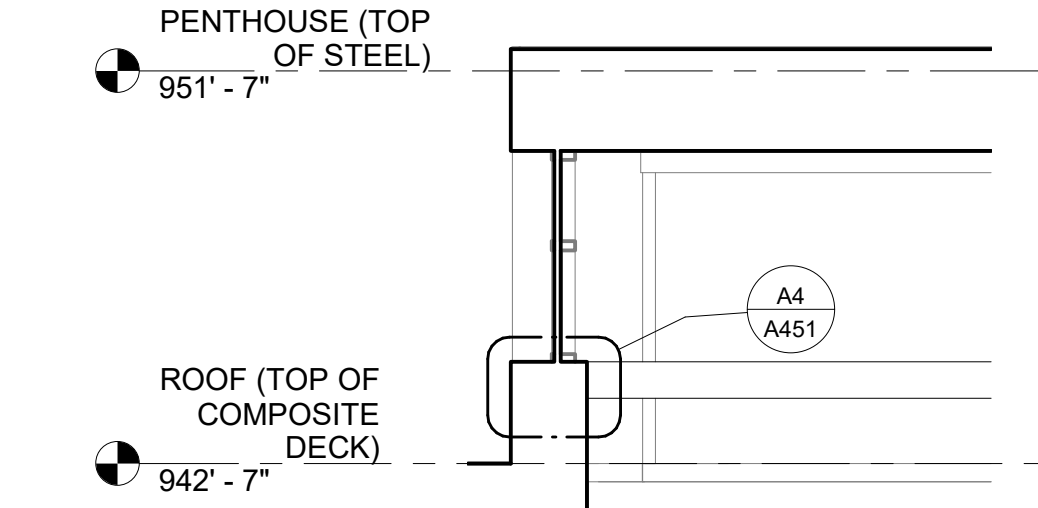

A1 STAIR
1/4" = 1'-0"

B4 ACCESS PANEL DETAIL - TYP
1 1/2" = 1'-0"

A4 UPLIGHTING SHELF DETAIL
1 1/2" = 1'-0"

RFI Form

RFI/ Response Index	Page/ Dwg./Spec./Rep. Number	Section/ Paragraph/ Topic	RFI	Design Team Response
1			The specifications state this is to be hand delivered to facilities, and the attached SUCF descriptions say it's the EB bidding module. Can you please confirm and verify how these bids are to be turned in?	Documents are to be hand-delivered to 121 Humphreys Service Building per the documents as this is an State bid.
2	A151		Lighting schedule missing.	See Addendum No. 1, Item 3.