


**CORNELL UNIVERSITY CALS
RENOVATE CALS GREENHOUSES
PHASE 1**

SUCF #: 161027

**100% BID DOCUMENTS
APRIL 7, 2020**

**105 CALDWELL RD
ITHACA, NY 14853**

DRAWING LIST - PHASE 1	
SHEET NO.	TITLE
GENERAL	
A0.00A A0.01A A0.02A A0.03A	COVER SHEET GENERAL NOTES, SYMBOLS & ABBREVIATIONS CODE SUMMARY & CODE COMPLIANCE PLAN SITE PHASING PLANS
ABATEMENT	
AA1.01A	ASBESTOS ABATEMENT PLAN
CIVIL	
C1.01A C1.02A C1.03A C1.04A C1.05A C1.06A C2.01 C2.02	EXISTING CONDITIONS PLAN - PHASE 1 DEMOLITION PLAN - PHASE 1 EROSION AND SEDIMENT CONTROL PLAN - PHASE 1 LAYOUT PLAN - PHASE 1 GRADING AND DRAINAGE PLAN - PHASE 1 UTILITY PLAN - PHASE 1 DETAILS DETAILS
ARCHITECTURAL	
A1.01A A2.01A A2.02A A2.10A A2.20A A2.30A A3.01A A4.01A A4.03A A6.00A A6.01A A6.02A A6.03A A6.04A A6.05A A7.00A A7.01A A7.02A A7.03A A7.04A A8.01A A9.00A A9.01A A9.03A A9.04A A10.01A	DEMOLITION PLAN - PHASE 1 FIRST FLOOR PLAN - PHASE 1 ROOF PLAN - PHASE 1 HEADHOUSE PLAN HEADHOUSE ROOF PLAN HEADHOUSE FOUNDATION DRAINAGE PLAN EXTERIOR ELEVATIONS - PHASE 1 BUILDING SECTIONS - PHASE 1 WALL SECTIONS ENLARGED EXTERIOR ELEVATIONS AND SECTIONS EXTERIOR DETAILS EXTERIOR DETAILS EXTERIOR DETAILS EXTERIOR DETAILS EXTERIOR DETAILS WALL TYPES - PHASE 1 DOOR SCHEDULE - PHASE 1 FINISH SCHEDULE - HEADHOUSE INTERIOR ELEVATIONS - HEADHOUSE INTERIOR ELEVATIONS - ALTERNATE #1 - PEST SPRAY AREA HEADHOUSE REFLECTED CEILING PLAN EQUIPMENT LIST - HEADHOUSE CASEWORK TYPES & ENLARGED DETAILS ENLARGED PLANS - AUTOCLAVES ENLARGED PLANS & ELEVATIONS - HEADHOUSE HEADHOUSE FURNITURE PLAN
STRUCTURAL	
S0.01 S0.02 S0.03 S2.10 S2.11 S4.01 S4.02 S4.03 S4.04 S4.05 S4.06 S5.01 S5.02	STANDARD ABBREVIATIONS GENERAL NOTES STRUCTURAL DESIGN CRITERIA HEADHOUSE FOUNDATION PLAN HEADHOUSE ROOF PLAN EXCAVATION AND WALL FOOTING TYPICAL DETAILS SLAB ON GRADE, GRADE BEAM AND DRAIN TYPICAL DETAILS FLOOR CURBS AND WALL TYPICAL DETAILS REINFORCED CMU WALL TYPICAL DETAILS REINFORCED CMU WALL TYPICAL DETAILS OPEN WEB JOISTS TYPICAL DETAILS SECTIONS AND DETAILS SECTIONS AND DETAILS
MECHANICAL	
H0.00A H2.00A H2.01A H2.10A H2.11A H6.00A H7.00A H7.01A H7.02A H7.03A H7.04A H7.05A H7.06A H7.07A H7.08A H7.09A H8.00A H8.01A H9.00A H9.01A	GENERAL NOTES & SYMBOLS - HVAC HEADHOUSE - NEW WORK PLAN - HVAC PIPING HEADHOUSE ROOF - NEW WORK PLAN - HVAC PIPING HEADHOUSE - NEW WORK PLAN - HVAC PIPING GREENHOUSE - NEW WORK PLAN - HVAC PIPING HOT WATER SYSTEM PIPING SCHEMATIC - NEW WORK CONTROL SCHEMATIC & SYSTEM SUMMARY CONTROL SCHEMATIC & SYSTEM SUMMARY CONTROL SCHEMATIC & SYSTEM SUMMARY CONTROL SCHEMATIC & SYSTEM SUMMARY CONTROL SCHEMATIC & SYSTEM SUMMARY CONTROL SCHEMATIC & SYSTEM SUMMARY CONTROL SCHEMATIC & SYSTEM SUMMARY CONTROL SCHEMATIC & SYSTEM SUMMARY CONTROL SCHEMATIC & SYSTEM SUMMARY CONTROL SCHEMATIC & SYSTEM SUMMARY CONTROL SCHEMATIC & SYSTEM SUMMARY CONTROL SCHEMATIC & SYSTEM SUMMARY CONTROL SCHEMATIC & SYSTEM SUMMARY CONTROL SCHEMATIC & SYSTEM SUMMARY CONTROL SCHEMATIC & SYSTEM SUMMARY DETAILS DETAILS SCHEDULES AIRFLOW SCHEDULES
PLUMBING	
P0.00A P1.01A P1.02A P2.01A P2.02A P2.03A P2.04A P2.05A P3.01A P5.00A	GENERAL NOTES, SYMBOLS LIST & SCHEDULES - PLUMBING GREENHOUSE - DEMOLITION PLAN - PLUMBING - AREA 1 GREENHOUSE - DEMOLITION PLAN - PLUMBING - AREA 2 GREENHOUSE - BELOW GRADE NEW WORK PLAN - PLUMBING - AREA 1 GREENHOUSE - NEW WORK PLAN - PLUMBING - AREA 1 GREENHOUSE - NEW WORK PLAN - PLUMBING - AREA 2 GREENHOUSE - NEW WORK PLAN - PLUMBING - AREA 4 GREENHOUSE - NEW WORK ROOF PLAN - PLUMBING - AREA 1 GREENHOUSE - ENLARGED PLANS - PLUMBING DETAILS - PLUMBING
ELECTRICAL	
E0.00A E0.01A E1.00A E3.00A E3.01A E4.00A E5.00A E5.01A E5.02A E5.03A E6.00A E6.01A E6.02A E6.03A E7.00A E7.01A E7.02A E7.03A E7.04A E8.00A	GENERAL NOTES & SYMBOLS LIST PHASE 1 ELECTRICAL PHASE 1 SITE PLAN NEW WORK ELECTRICAL PHASE 1 DEMOLITION PLAN - ELECTRICAL PHASE 1 - BASEMENT & FIRST FLOOR OVERALL PLAN - POWER PHASE 1 - ROOF - NEW WORK PLAN - POWER PHASE 1 - BASEMENT & FIRST FLOOR OVERALL PLAN - TEL/DATA ENLARGED IT ROOM NEW WORK PLAN - ELECTRICAL HEADHOUSE - BASE BID & ADD ALT #1 - SHEET 1 HEADHOUSE - BASE BID & ADD ALT #1 - SHEET 2 ENLARGED 1098L - ELECTRICAL PHASE 1 - ONE LINE DIAGRAM - ELECTRICAL PHASE 1 - ONE LINE DIAGRAM - ELECTRICAL PHASE 1 - ONE LINE DIAGRAM - TEL/DATA PHASE 1 - CARD ACCESS RISER DIAGRAM - NEW WORK PHASE 1 - FIRE ALARM ONE LINE DIAGRAM - NEW WORK PHASE 1 - ELECTRICAL DETAILS SHEET #1 PHASE 1 - ELECTRICAL DETAILS SHEET #2 PHASE 1 - ELECTRICAL DETAILS SHEET #3 PHASE 1 - ELECTRICAL DETAILS SHEET #4 PHASE 1 - ELECTRICAL DETAILS SHEET #5 PHASE 1 - ELECTRICAL SCHEDULES SHEET #1

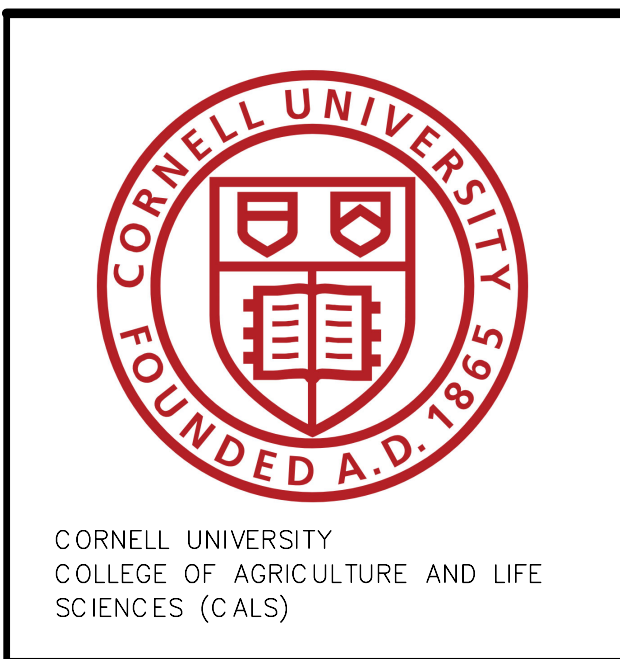


ARCHITECT:
Mitchell Giurgola
Mitchell Giurgola Architects LLP
630 Ninth Avenue, Suite 711
New York, New York 10036
212 663 4000

MEP ENGINEER:
M/E Engineering, P.C.
300 Trolley Boulevard
Rochester, NY 14606
585 288 5590

STRUCTURAL ENGINEER:
LERA Consulting Structural Engineers
40 Wall Street, 23rd Floor
New York, NY 10005
212 750 9000

LEED CONSULTANT:
M/E Engineering, P.C.
300 Trolley Boulevard
Rochester, NY 14606
585 288 5590

COST ESTIMATING:
Trophy Point, L.L.C.
4588 South Park Avenue
Blossfield, NY 14219
716 823 0006

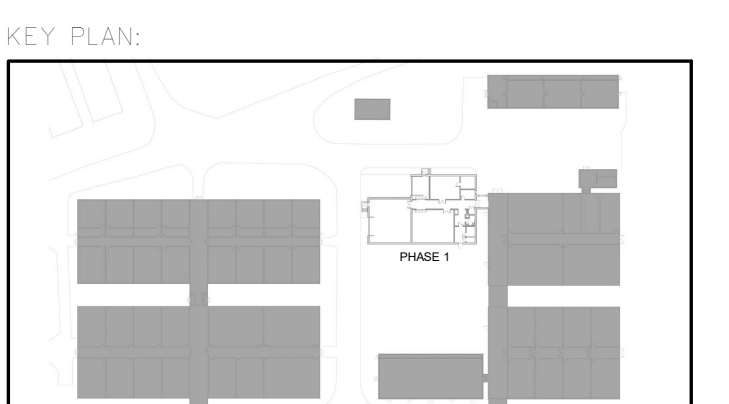

ISSUE/REVISION		
NO.	DATE	COMMENTS

PROJECT:
RENOVATE CALS GREENHOUSES

PHASE 1

DRAWING TITLE:
COVER SHEET - PHASE 1

PROJECT NO: 191900 **DATE: 4-7-20**
PHASE: BID DOCUMENTS **SCALE: 1" = 1'-0"**

A0.00A

SUCF #: 161027